



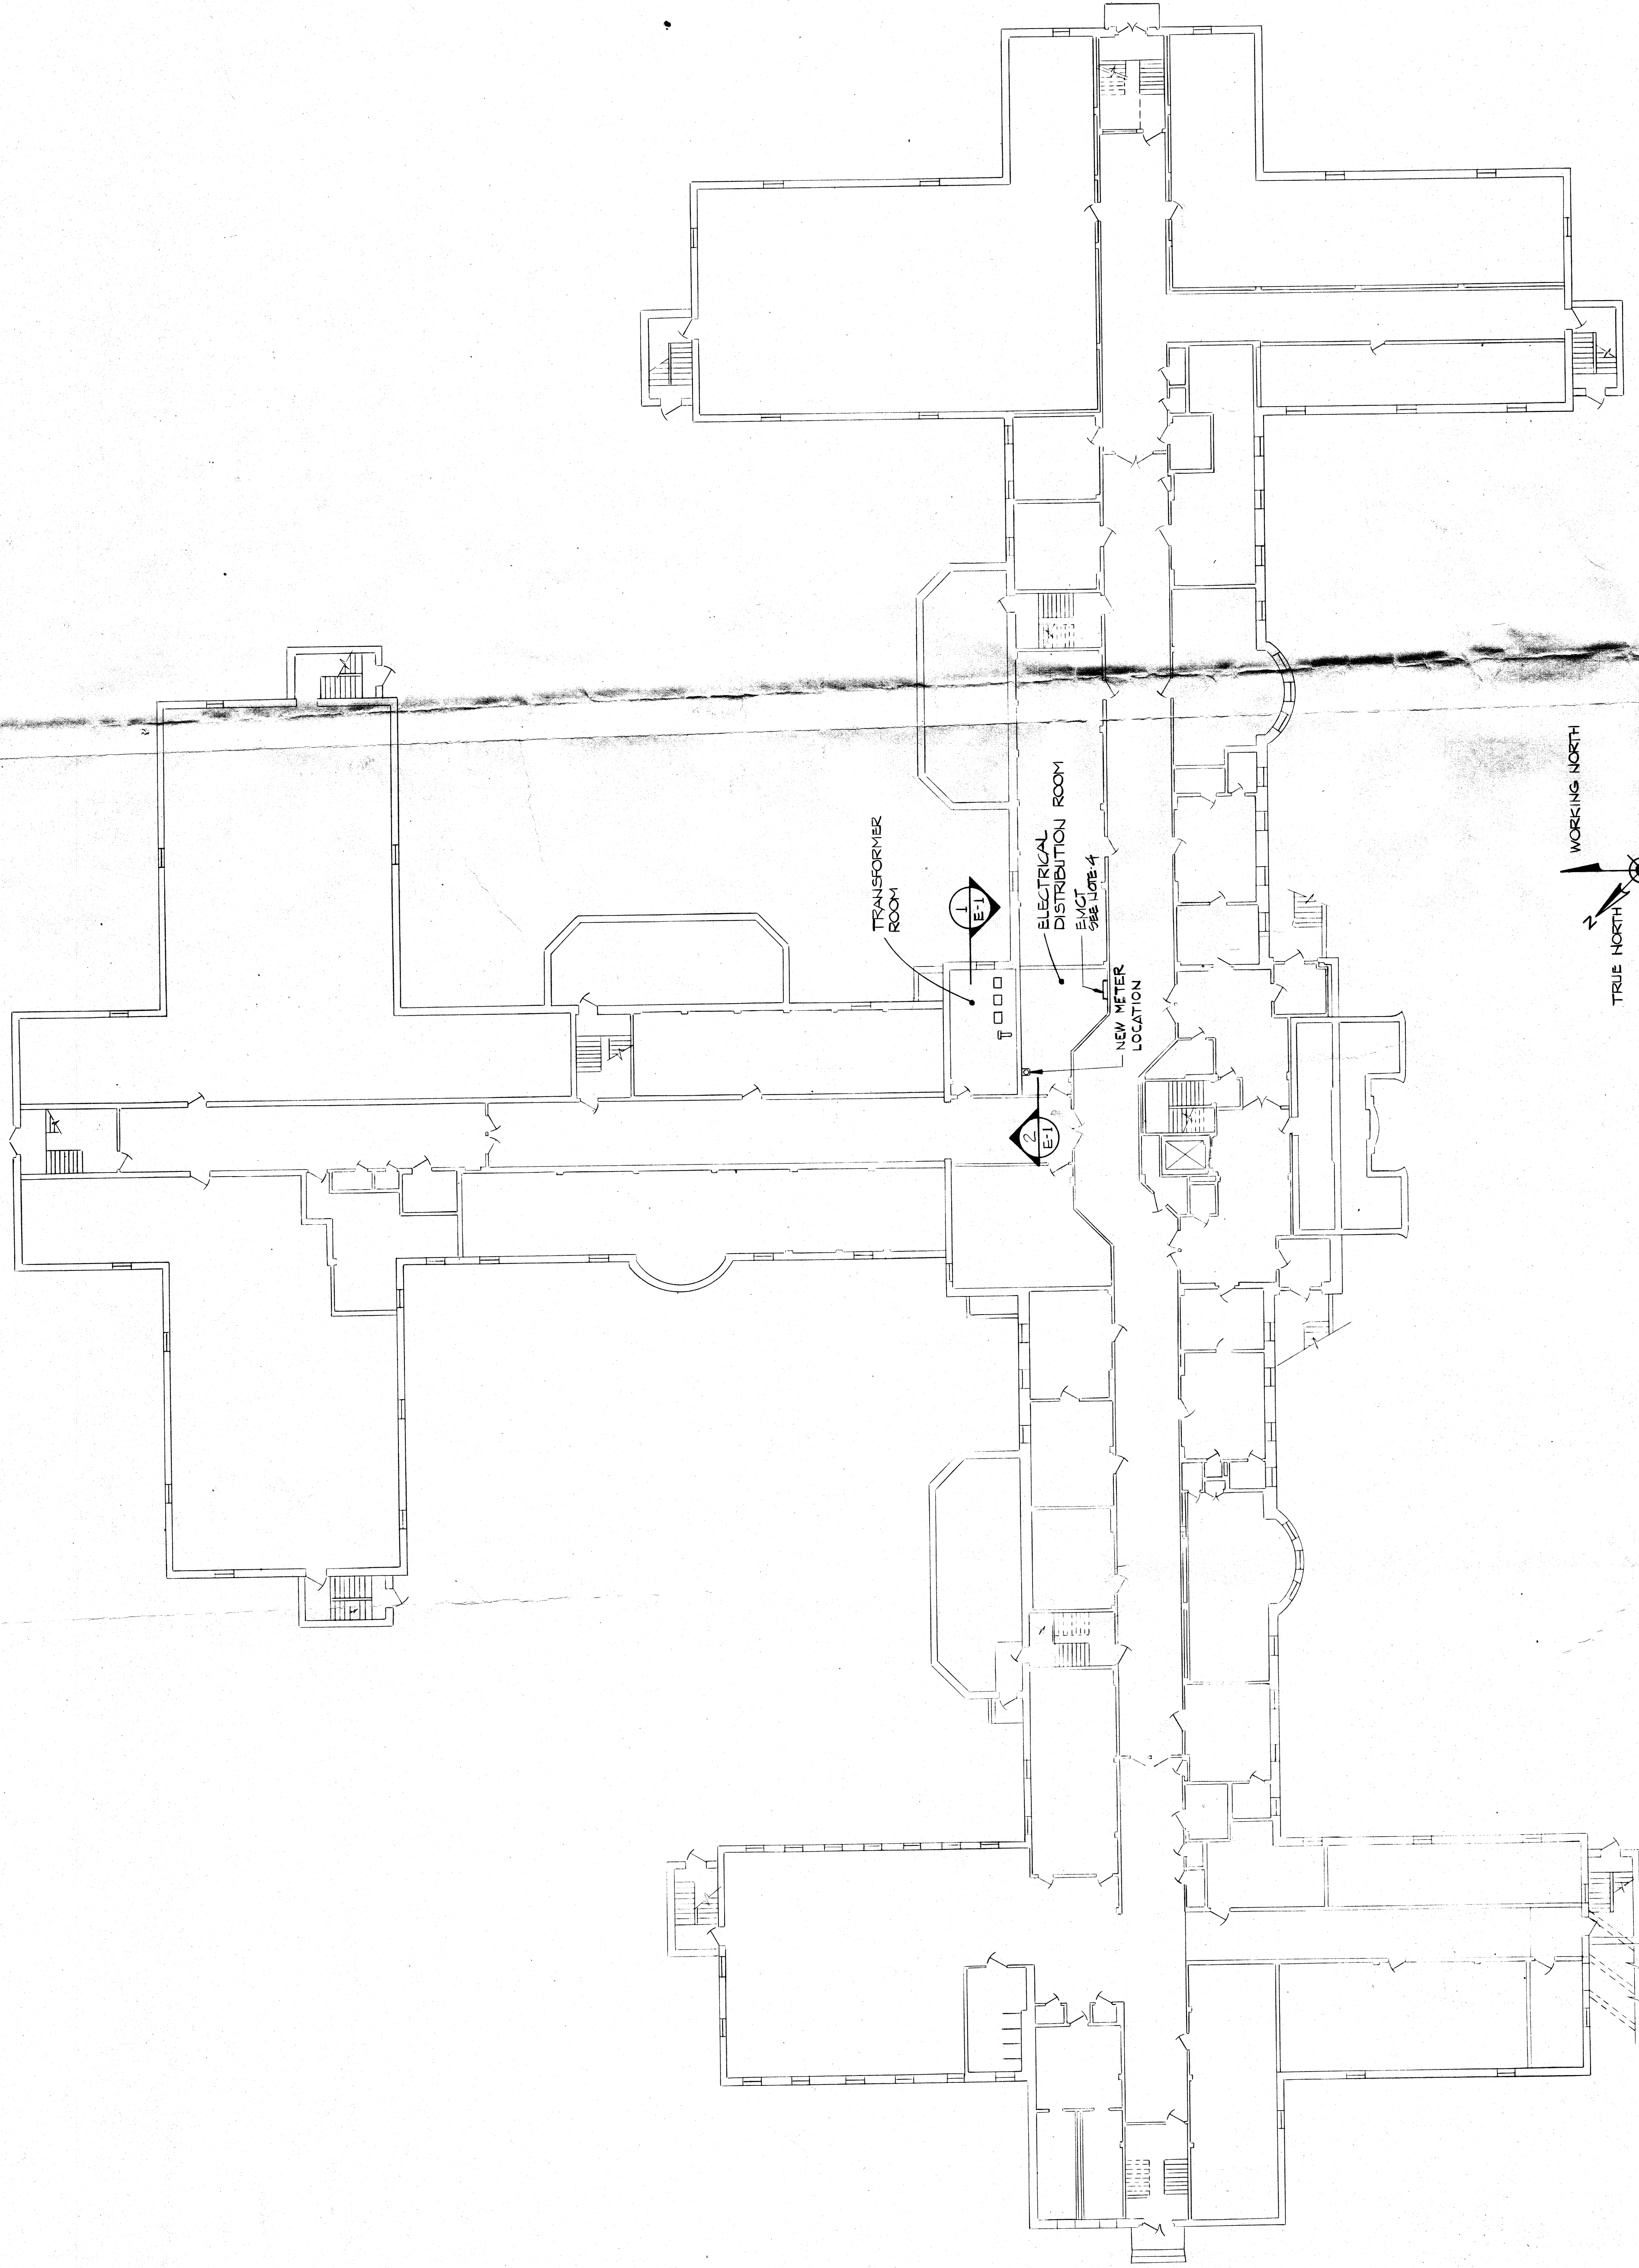


BASEMENT FLOOR PLAN
SCALE: 1/16"=1'-0"

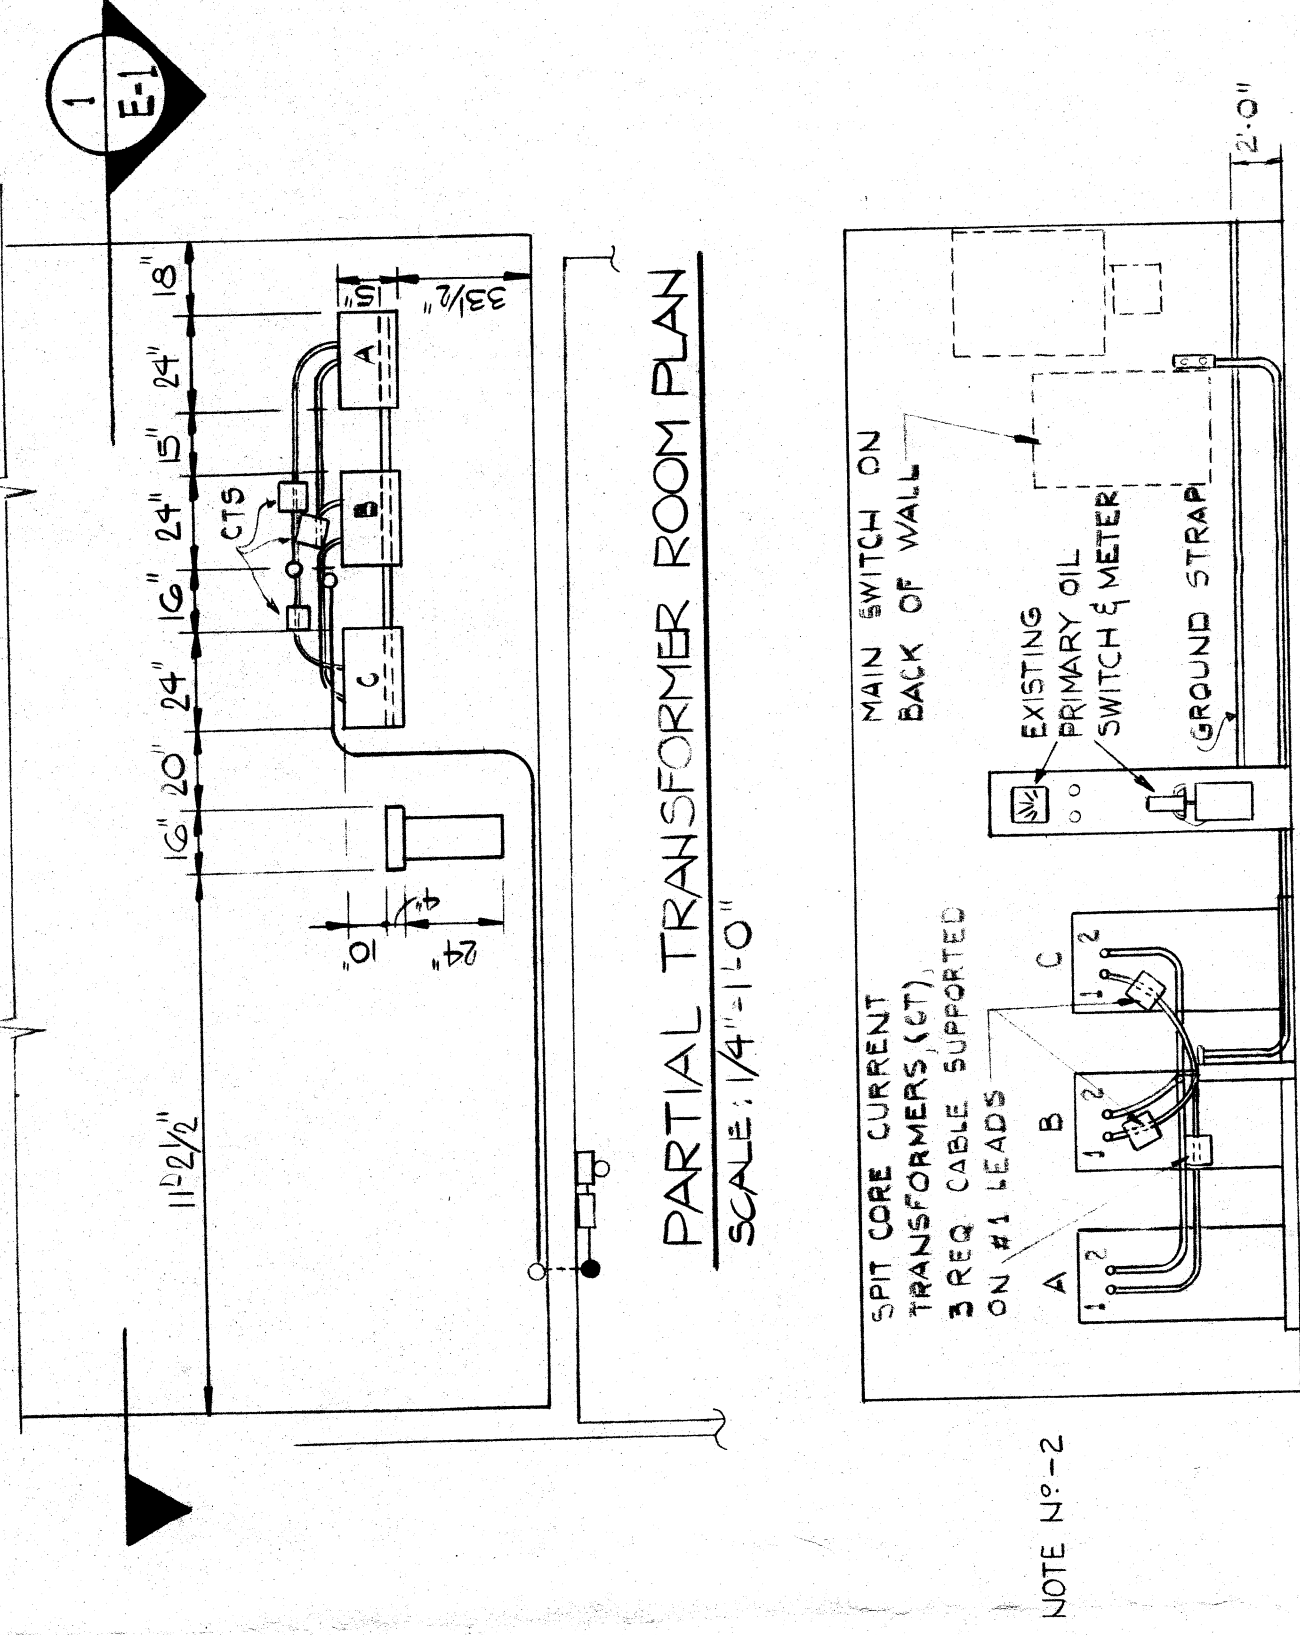

PARTIAL TRANSFORMER ROOM PLAN
SCALE: 1/4"=1'-0"

NOTE N#-2

ELEVATION
SCALE: 1/4"=1'-0"

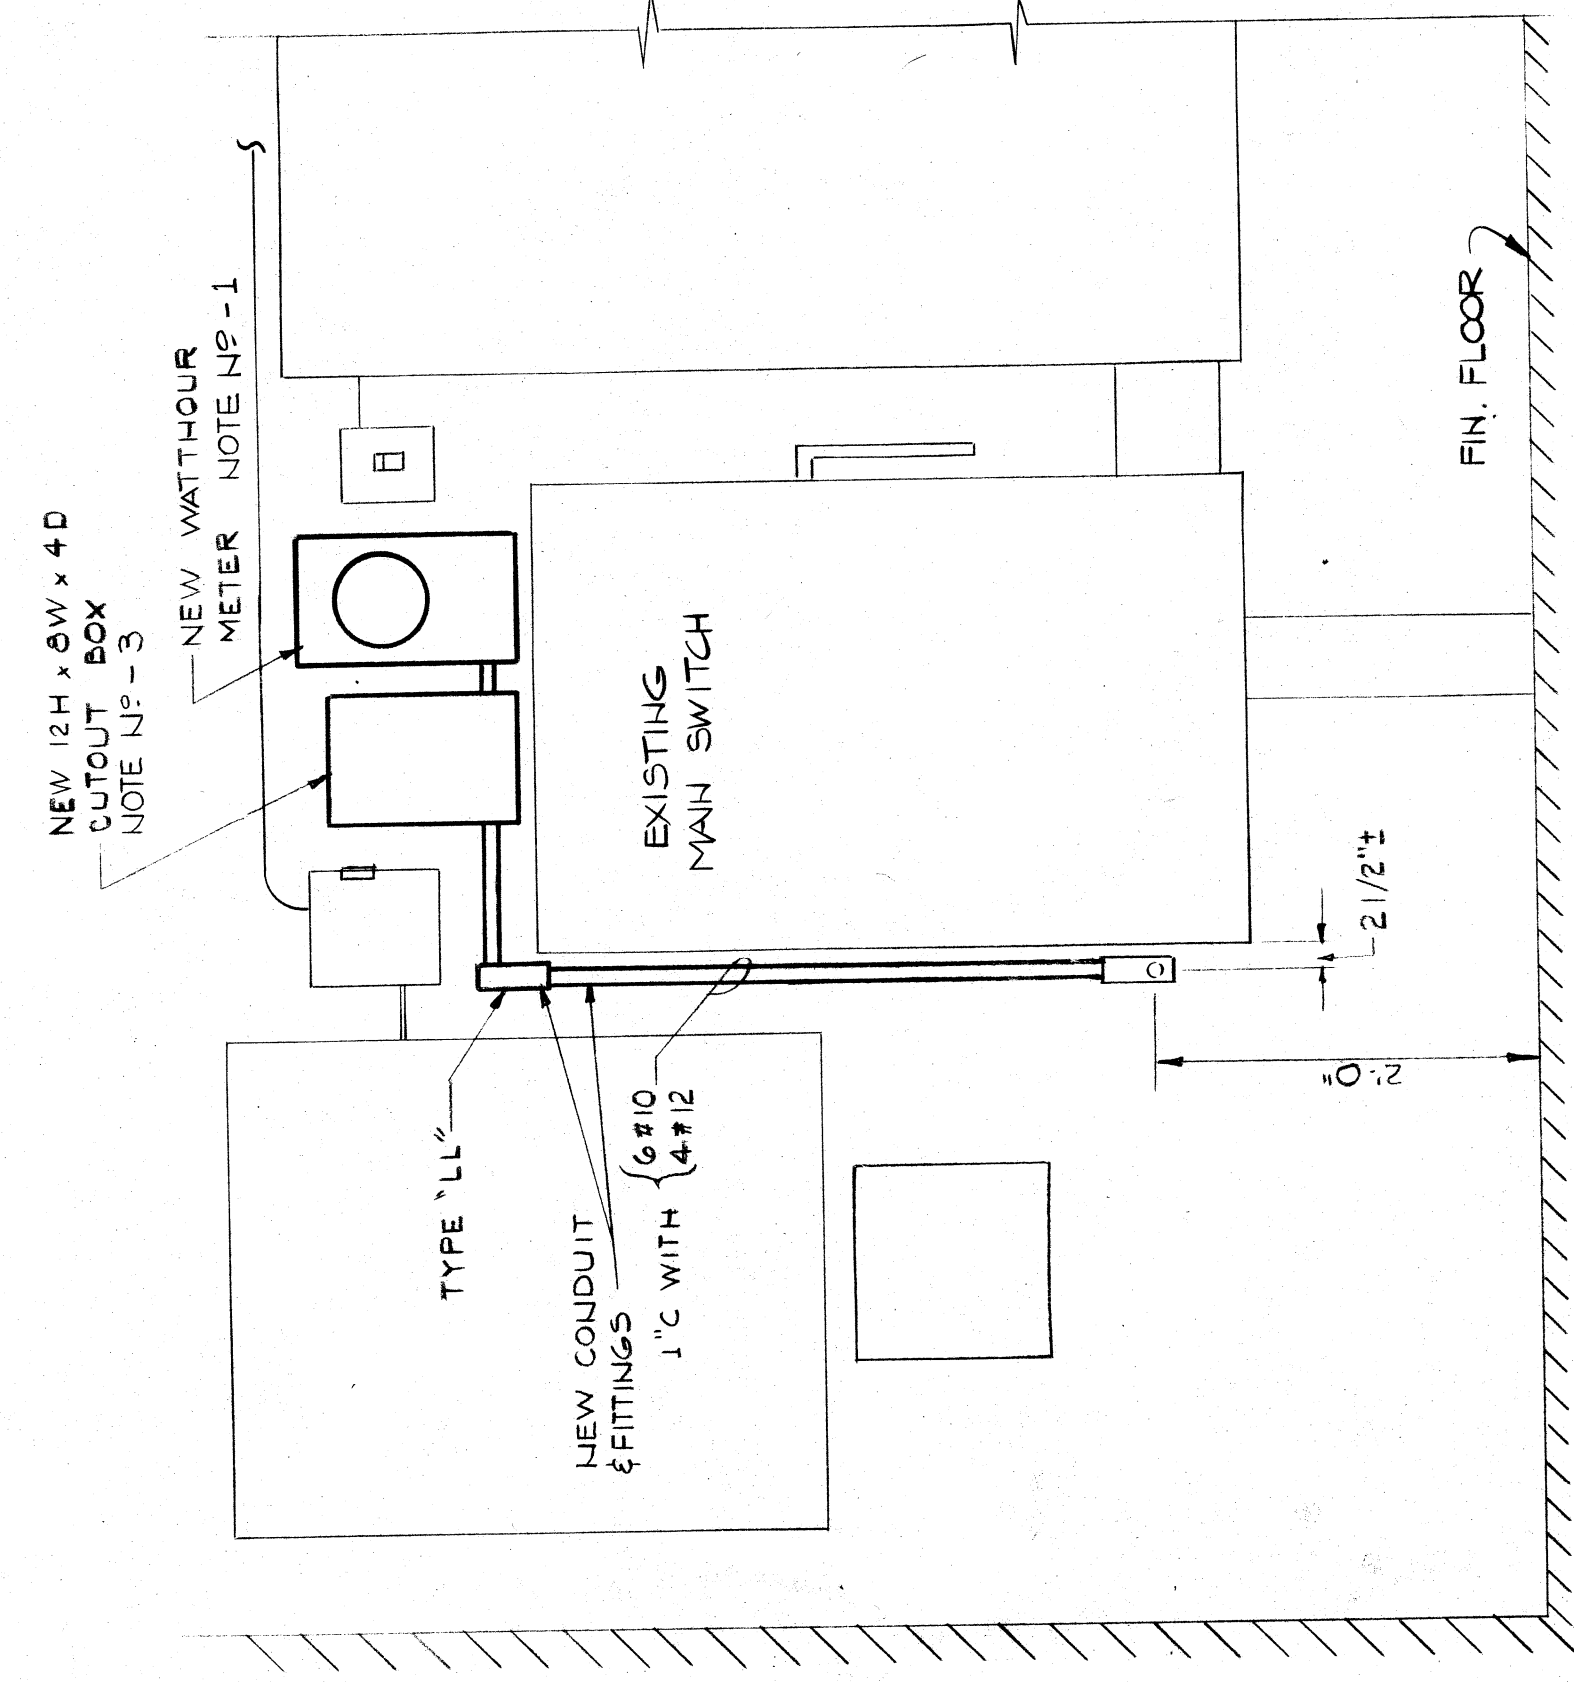

ELEVATION
SCALE: 1/4"=1'-0"

- NOTES:
- 1-CONNECT WATTHOUR METER IN ACCORDANCE WITH MANUFACTURERS INSTRUCTIONS.
 - 2-CONNECT CURRENT TRANSFORMERS AND MAKE POTENTIAL TAPS AT THE POWER TRANSFORMER TERMINALS IN ACCORDANCE WITH MANUFACTURERS INSTRUCTIONS.
 - 3-PROVIDE A MINIMUM OF 12 INCHES OF COILED LENGTH OF EACH METER CIRCUIT CONDUIT TO THE CUT OUT BOX FOR FUTURE REPAIRS/CONNECTIONS.
 - 4-CONDUIT SHALL BE RIGIDLY SUPPORTED AT 6' INTERVALS. CUT OUT BOX SHALL BE 12" MIN. FROM WALL. BREAKER 20A IN EMERGENCY LIGHT PANEL ON NORTH WALL CONNECTIONS OF LOW VOLTAGE CABLE AND SENSOR WIRING WILL BE BY THE MECHANICAL CONTRACTOR AS SHOWN ON DWG'S M-1 & M-2

REVISED: DEC. 7, 1981

DRAWING TITLE	
PLANS PREPARED BY	
STATE OF CONNECTICUT	
DEPARTMENT OF ADMINISTRATIVE SERVICES - BUREAU OF PUBLIC WORKS	
PROJECT TITLE	
AS NOTED	
DRAWN BY	DATE
CHECKED BY	DATE
APPROVED BY	DATE
PROJECT NUMBER	OF
E-1	